


REVISIONS			
LTR	DESCRIPTION	DATE	APPROVED
E	ECD# 2012-120	12/10/11	WHB

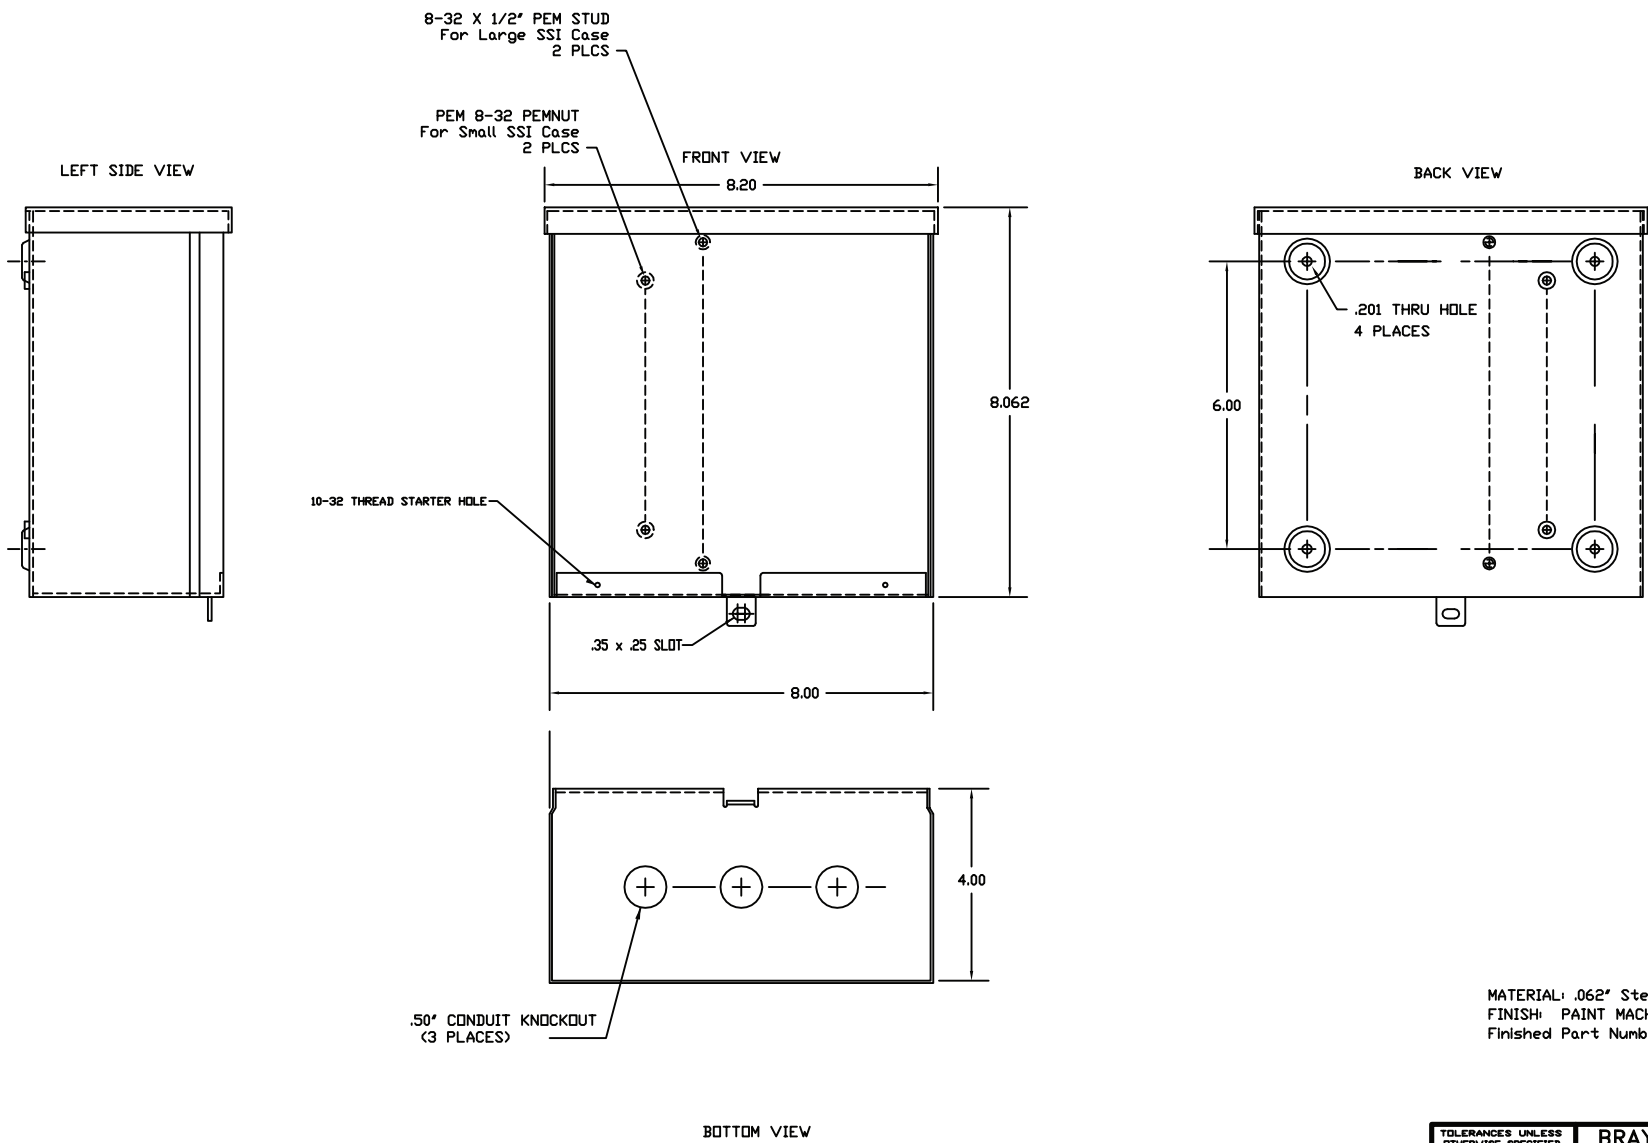

MATERIAL: .062" Steel
 FINISH: PAINT MACHINERY GRAY ENAMEL
 Finished Part Number: 09200-22032E

TOLERANCES UNLESS OTHERWISE SPECIFIED		BRAYDEN AUTOMATION CORP. 6230 AVIATION CIRCLE, LOVELAND, CO. 80538	
.XX = +/- .020		TITLE: MODEL SSI 8 x 8 RELAY NEMA 3R ENCLOSURE	
APPROVALS	DATE	DRAWN: WHB 8/18/10	
CHECKED	SCALE:	DRAWING NUMBER:	
	1 : 2	C-09200-22032-01	
DO NOT SCALE DRAWING		SHEET: 1 of 1	